


AREA 1 : FUNCTION ROOM.

AREA 2 : ALCOHOL STORAGE / DELIVERIES.

Manchester Victoria College
Fire Escape Floor Plan (Ground Floor)

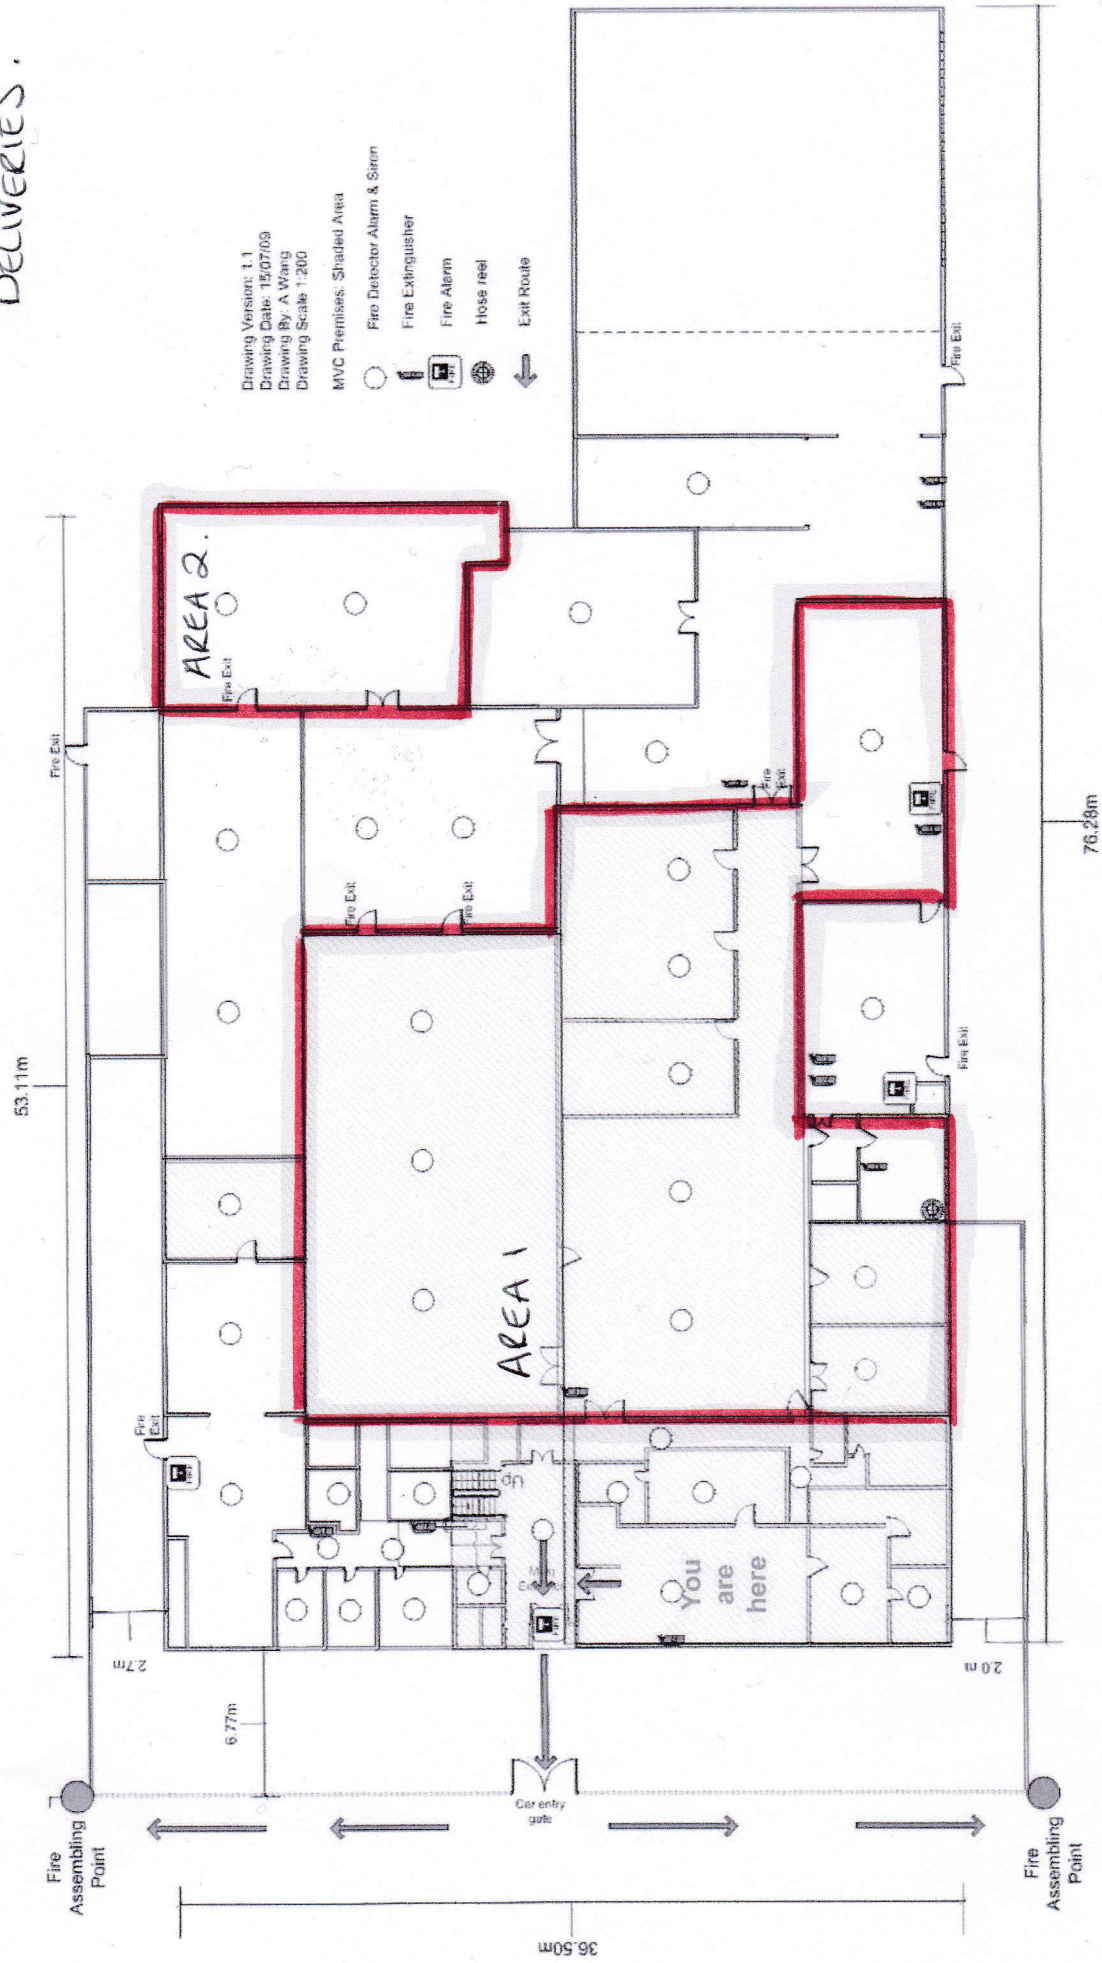

Drawing Version: 1.1
Drawing Date: 15/07/09
Drawing By: A Wang
Drawing Scale: 1:200

- MVC Premises, Shaded Area
- Fire Detector Alarm & Siren
- Fire Extinguisher
- Fire Alarm
- Hose reel
- Exit Route