

KEY TO WALLS	
	EXISTING WALL
	NEW FULL HEIGHT STUD CONSTRUCTION

FIRE SAFETY LEGEND	
	FIRE ALARM CALL POINT
	9 LITRE WATER FIRE EXTINGUISHER
	2 KG CARBON DIOXIDE EXTINGUISHER (OR HALON)
	9 LITRE FOAM FIRE EXTINGUISHER
	FIRE BLANKET IN CONTAINER
	FLASHING BEACON
	AREA COVERED BY AUTOMATIC HEAT DETECTORS
	AREA COVERED BY AUTOMATIC SMOKE DETECTORS
	AREA COVERED BY EMERGENCY LIGHTING (BS 5266)
	PANIC BAR TO BE PROVIDED TO DOORS
	DOORS TO HAVE ONLY A SIMPLE FASTENING (WITHOUT USE OF A KEY, E.G. BARRIE L BOLT)
	SIGN FOR DOOR TO BE KEPT SHUT 1MM LETTERS (BS5400)
	SIGN FIRE DOOR KEEP LOCKED (BS5400)
	SIGN FIRE ESCAPE KEEP CLEAR (BS5400)
	SIGN FIRE EXIT OR GRAPHIC EQUIVALENT 7MM LETTERS (BS5400)
	DIRECTIONAL ARROW TO BE PROVIDED WITH REFLECTIVE (BS5400)
	ILLUMINATED SIGN - FIRE EXIT OR GRAPHIC EQUIVALENT 7MM LETTERS (BS5400)
	FIRE ALARM SIREN
	30 MINS FIRE PROTECTED DOOR W/ SMOKE SEALANTS
	60 MINS FIRE PROTECTED DOOR W/ SMOKE SEALANTS
	ALARM ACTIVATED ELECTRONIC STAY
	FIRE ALARM REPEATER PANEL

* Fire alarm system to be in accordance with BS5833
 * Fire exit signage to be in accordance with BS5400

LICENSED AREA	
	RED LINE INDICATES AMBIT OF LICENSED AREA
	NEW LICENSE DEMISE

PL000208/021216




A GROUND FLOOR PLAN
SCALE 1:50@A1

CANTOR CM MASTERS
INTERIOR DESIGN

No1 The Colour House
7 Bell Yard Mews
London SE1 3UA
Tel: +44(0)20 7407 5434
e: info@cantormasters.com
www.cantormasters.com

CLIENT		
COTE RESTAURANTS		
PROJECT		
183 ASHLEY ROAD		
HALE		
ALTRINCHAM WA15 9SD		
DRAWING		
PLANS FOR LICENSING		
1 OF 2		
JOB No:	SCALE	DATE
13916	1:50	04.10.16
DRAWING No:	REVISION	
LI.01	-	A1 SHEET

© Copyright is reserved by CantorMasters Ltd
 This drawing is the property of CantorMasters Ltd and is issued on condition that it is not copied or in any manner or issued to third parties without the written consent from CantorMasters Ltd
 CantorMasters Ltd does not warrant the accuracy of the measurements or other information contained on the drawing and all parties using the drawing and the information contained within must check and verify and satisfy themselves as to the accuracy or otherwise of such measurements or other information.
 Do not scale from this drawing. All figured measurements are indicated as a general guide only.
 All discrepancies or omissions must be reported to CantorMasters Ltd for their comments or approval prior to commencing work.
 This drawing is to be read in conjunction with all other consultants information and any anomalies reported to CantorMasters Ltd prior to commencement on site.
 This drawing is subject to approval by statutory authorities and as such is subject to revision as required.

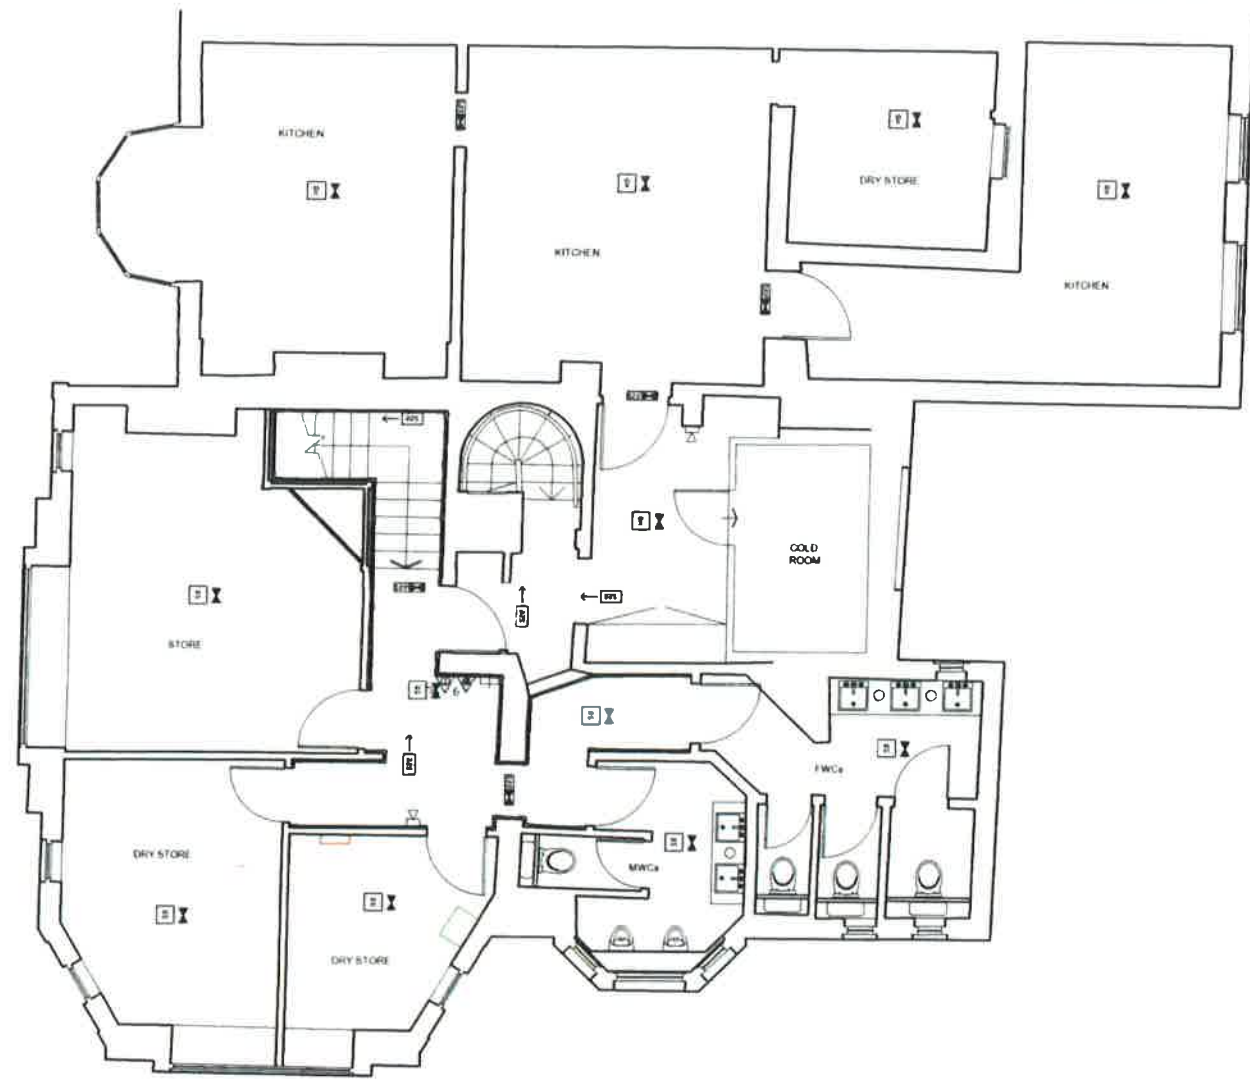

C FIRST FLOOR PLAN
SCALE 1:50@A1



B BASEMENT FLOOR PLAN
SCALE 1:50@A1

KEY TO WALLS	
	EXISTING WALL
	NEW FULL HEIGHT STUD CONSTRUCTION

FIRE SAFETY LEGEND	
	FIRE ALARM CALL POINT
	9 LITRE WATER FIRE EXTINGUISHER
	2 KG CARBON DIOXIDE EXTINGUISHER (OR HALON)
	9 LITRE FOAM FIRE EXTINGUISHER
	FIRE BLANKET IN CONTAINER
	FLASHING BEACON
	AREA COVERED BY AUTOMATIC HEAT DETECTORS
	AREA COVERED BY AUTOMATIC SMOKE DETECTORS
	AREA COVERED BY EMERGENCY LIGHTING (BS 6208) (3-FULL COVERAGE)
	PANIC BAR TO BE PROVIDED TO DOORS
	DOORS TO HAVE ONLY A SIMPLE FASTENING WITHOUT THE USE OF A KEY, E.G. BARRETT BOLT NIGHT LATCH
	SIGN 'FIRE DOOR KEEP SHUT' 1MM LETTERS (BS5489) (200% SIDE'S OF DOOR)
	SIGN 'FIRE DOOR KEEP LOCKED' (BS5489)
	SIGN 'FIRE ESCAPE KEEP CLEAR' (BS5489)
	SIGN 'FIRE EXIT OR GRAPHIC EQUIVALENT' 7MM LETTERS (BS5489)
	DESCRIPTIVE SIGN TO BE PROVIDED WITH SIGNIFICANCE (BS5489)
	ILLUMINATED SIGN, 'FIRE EXIT' OR GRAPHIC EQUIVALENT FROM LETTERS (BS5489)
	FIRE ALARM SOUNDER
	30 MINS FIRE PROTECTED DOOR W/ SMOKE SEALANTS
	60 MINS FIRE PROTECTED DOOR W/ SMOKE SEALANTS
	ALARM ACTIVATED ELECTRONIC STAY
	FIRE ALARM REPEATER PANEL

- Fire alarm system to be in accordance with BS6838
- Fire exit signage to be in accordance with BS5489

LICENSED AREA	
	RED LINE INDICATES AREA OF LICENSED AREA
	NEW LICENSE DEMISE

REVISION	DATE	DESCRIPTION

PLO00208/02216



CANTOR M MASTERS
INTERIOR DESIGN

No1 The Colour House
7 Bell Yard Mews
London SE1 3UA
Tel: +44(0)20 7407 5434
e: info@cantormasters.com
www.cantormasters.com

CLIENT		
COTE RESTAURANTS		
PROJECT		
183 ASHLEY ROAD		
HALE		
ALTRINCHAM WA15 9SD		
DRAWING		
PLANS FOR LICENSING		
2 OF 2		
JOB No.	SCALE	DATE
13916	1:50	04.10.16
DRAWING No.	REVISION	
LI.01	-	A1 SHEET

© Copyright is reserved by CantorMasters Ltd.
This drawing is the property of CantorMasters Ltd and is issued on condition that it is not copied or reproduced in any form or by any means without the written consent from CantorMasters Ltd.
CantorMasters Ltd does not warrant the accuracy of the measurements or other information contained on the drawing and all parties using the drawing and the information contained therein must check and verify and satisfy themselves as to the accuracy or otherwise of such measurements or other information.
Do not scale from this drawing. All square measurements are indicated as a general guide only. All discrepancies or omissions must be reported to CantorMasters Ltd for their comments or approval prior to commencing work.
This drawing to be read in conjunction with all other consultants information and any annotations reported to CantorMasters Ltd prior to commencement on site.
This drawing is subject to approval by statutory authorities and as such is subject to revision as required.