 

 





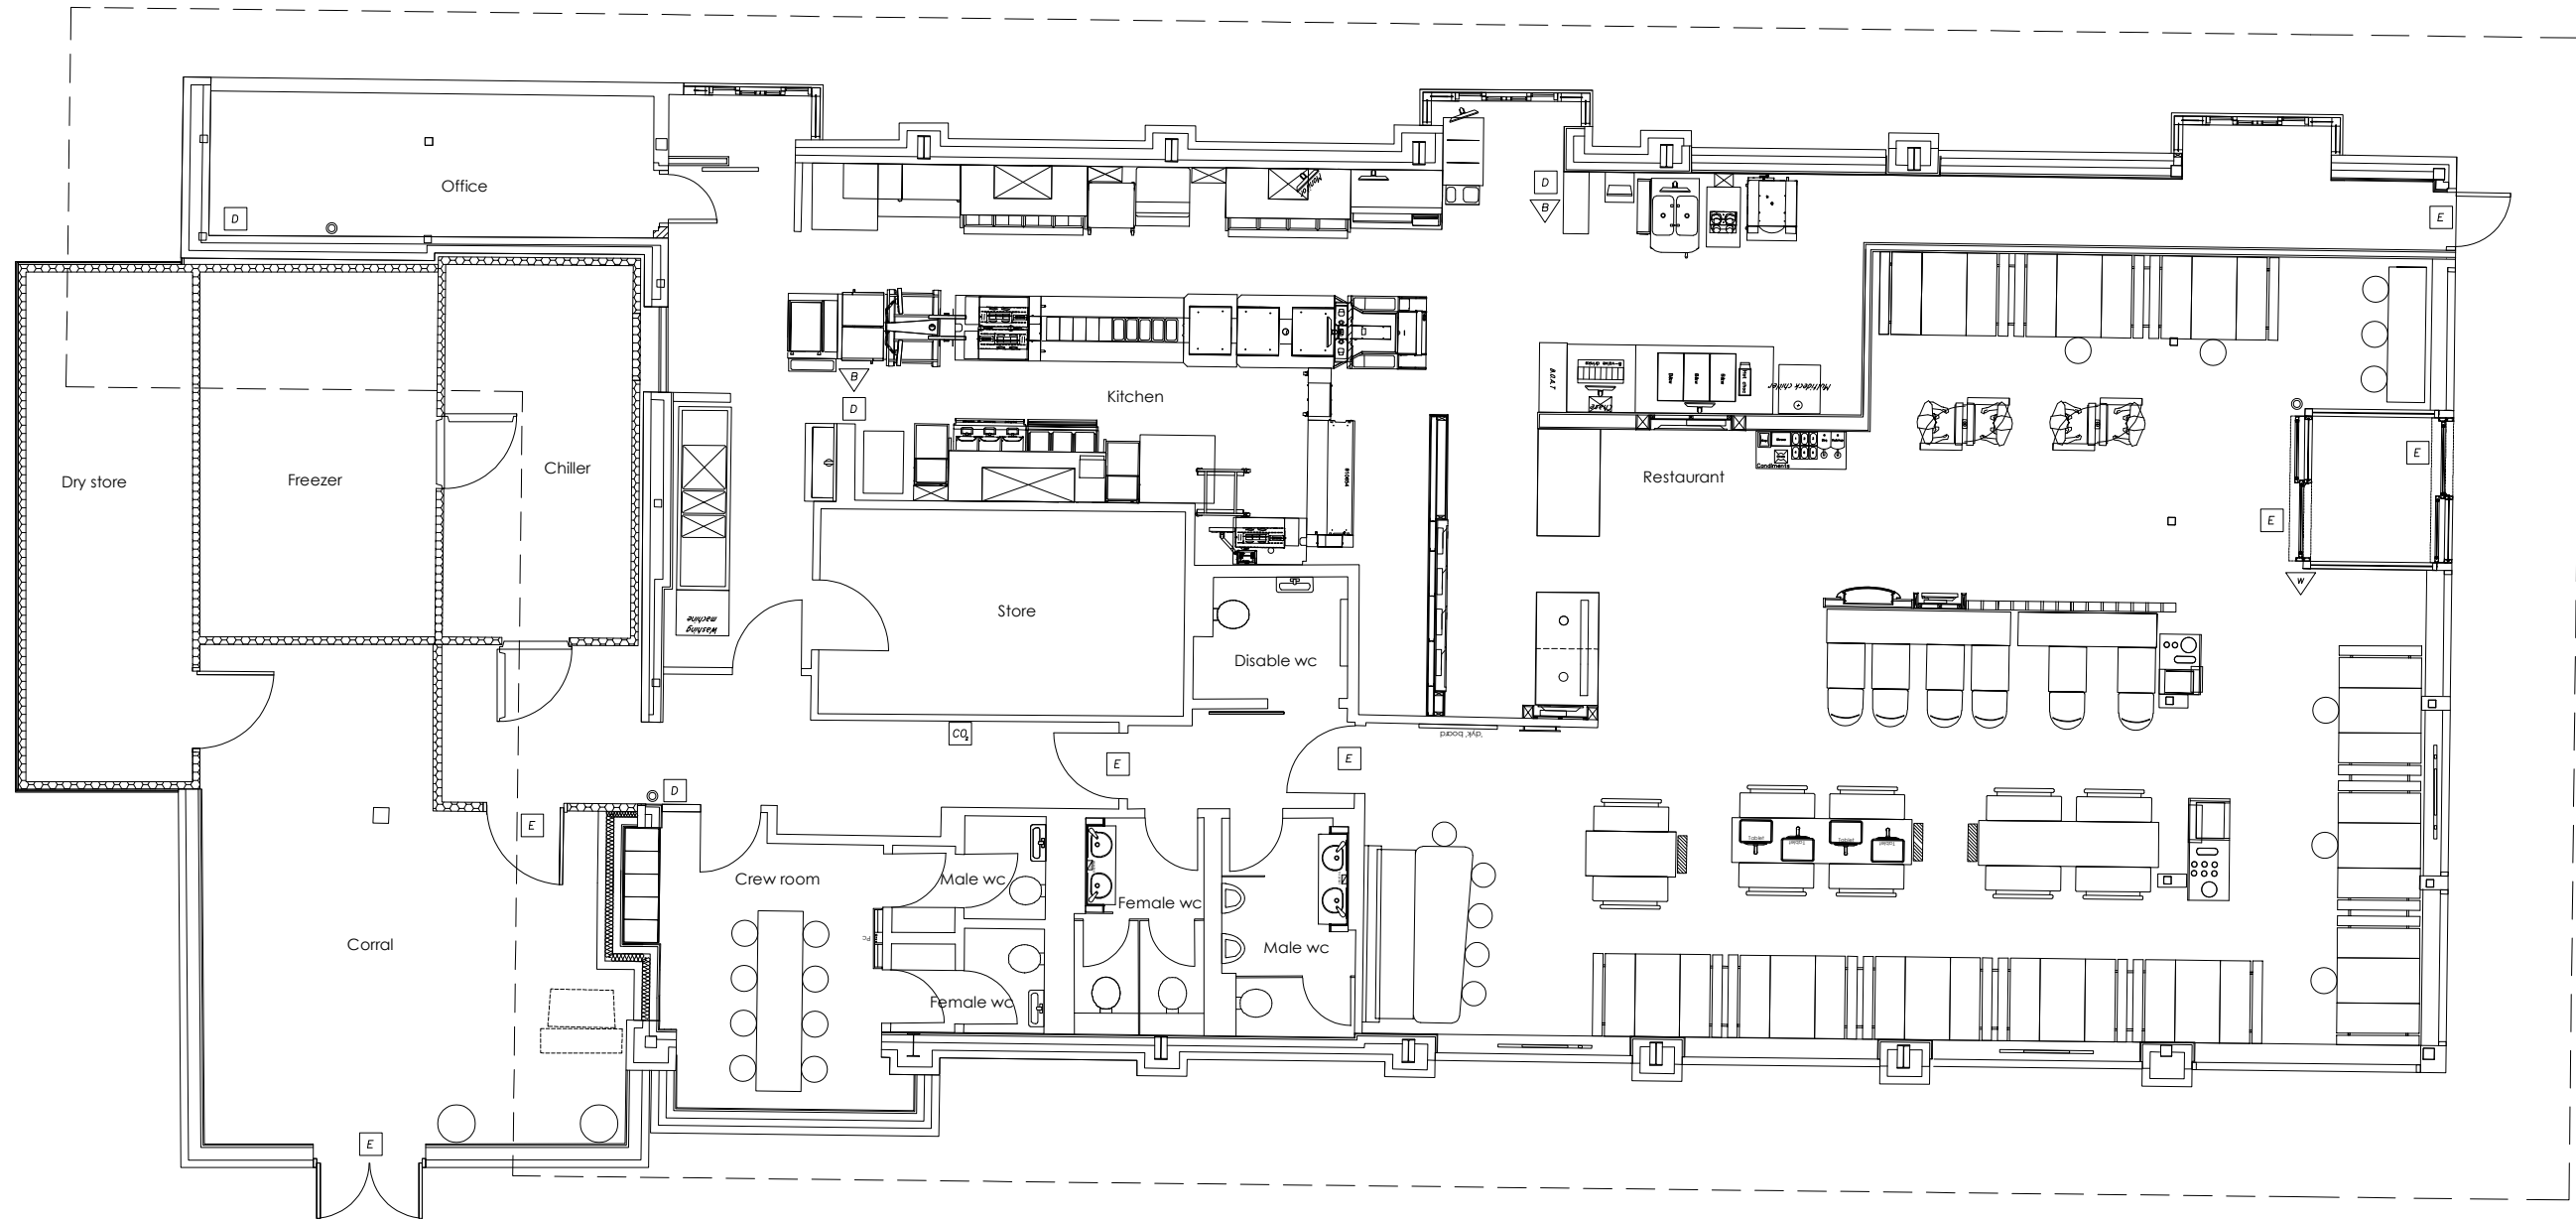


NOTES

FIRE SAFETY EQUIPMENT

-  CO2 Extinguisher
-  Extinguishers
-  Powder Extinguisher
-  Fire Blanket
-  Fire alarm call point
-  Fire Exit

Note:  
All fry stations have automatic fire suppression devices fitted.



Licensable activity:  
Sale of Hot food & Drink  
after 11pm.

Rev. Date. Amendments

PROJECT  
0829 Trafford Park

Neary Way  
Davyhulme  
Manchester,  
M17 1FP

0161 7499566

TITLE  
Ground floor plan  
(For Licencing)

Date:	Nov 2016	Drawn:	C.T.S.G.	Discipline:	Arch
Scale:	1:100@A3	Type:	DRG. No.	Issue:	002
			EX/0829/001		