



THE Pavilion Hale . 25 Cecil Road. Hale- WAIS ANT.

Scale 1:50

Internal CCTV ⊗ External CCTV x 8 \*

16-2-23.

1A Licensed Area.  
1A Locked Liquor Store

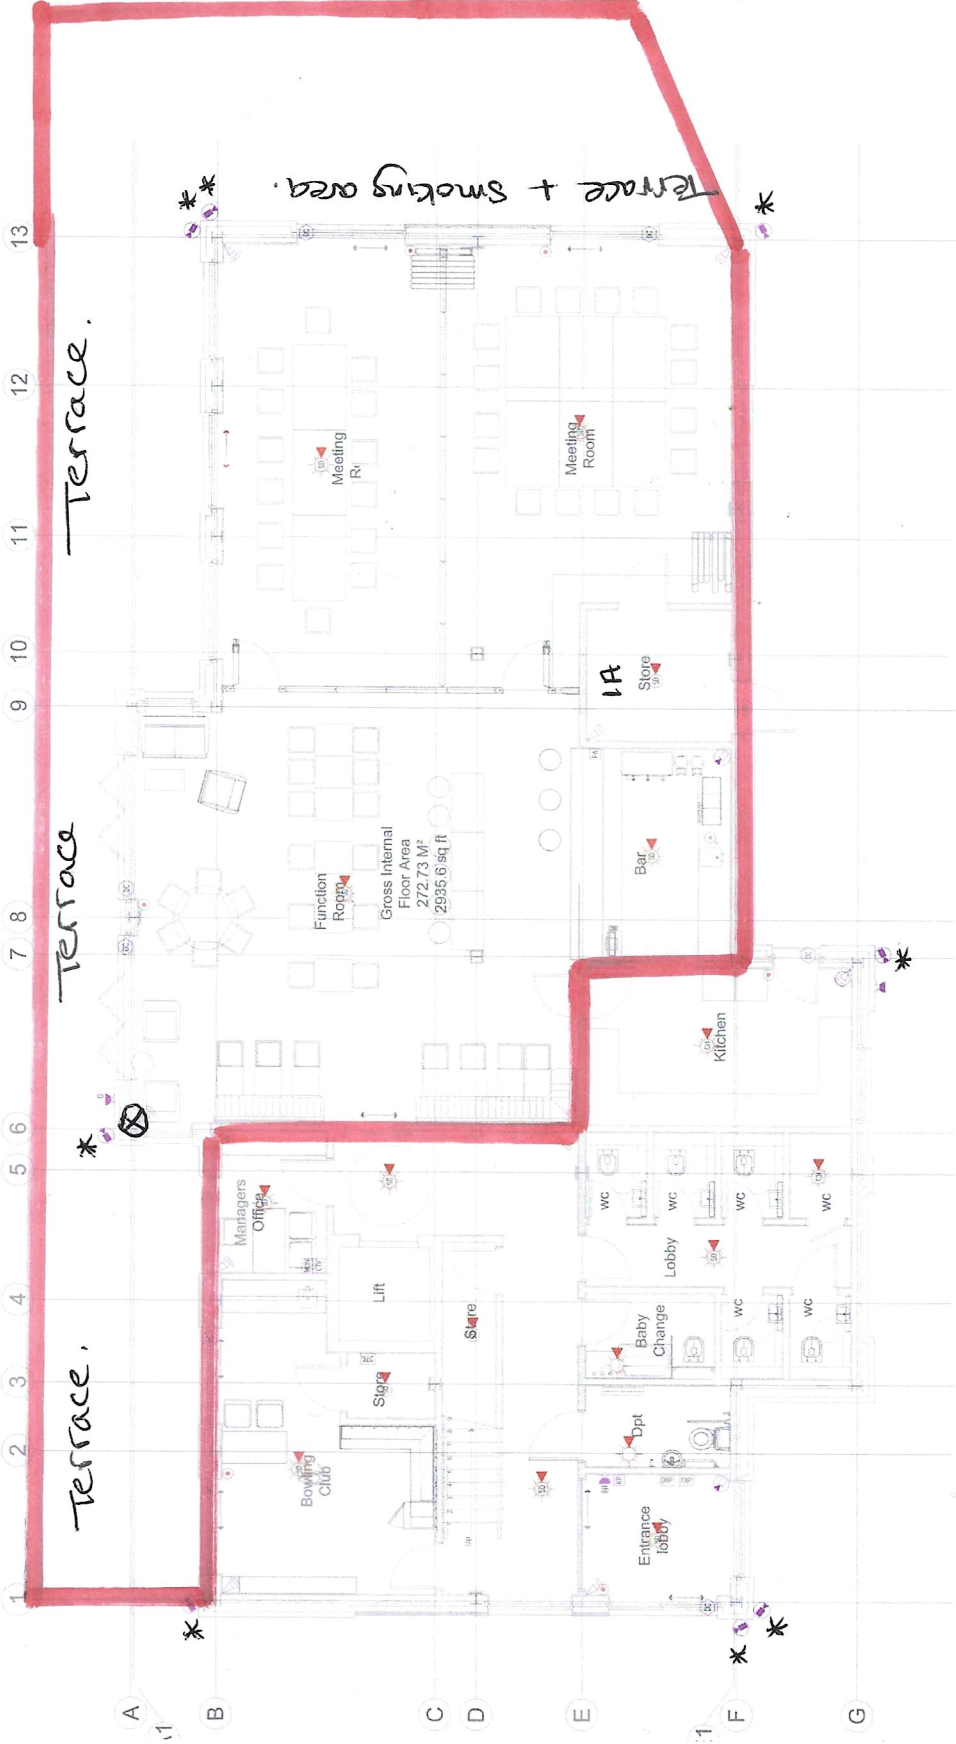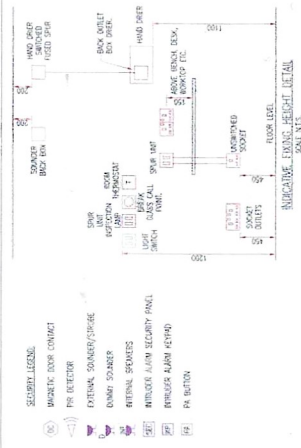

- Notes:**
- This drawing is subject to copyright and is not to be reproduced without prior approval.
  - Do not scale this drawing - check all dimensions on site.
  - This drawing shall be used in conjunction with the specification and all other contract documentation.
  - All dimensions are in millimetres unless otherwise stated.
  - Location of all equipment shown shall be confirmed to the Architect/Structural Engineer prior to any installation.
  - This drawing must be read in conjunction with the manufacturer's installation performance specifications and all other drawings to the Architect/Structural Engineer and Watt Energy & Consulting Engineers.
  - The location of equipment is typical only. The Contractor shall confirm the exact location of the equipment on site and ensure that the equipment is installed in accordance with the manufacturer's installation instructions.
  - This drawing shows the intended location of the equipment and service routes in each detail as to indicate the design. It is not intended to show all components that may be necessary in particular to a specific installation.
  - The positions of conductor paths, accessories and materials are shown for guidance in construction. The Contractor shall be responsible for the final installation and shall be liable for any damage to the building or its contents.

- LEGEND:**
- SMOKER DETECTOR
  - SMOKER DETECTOR WITH SOUNDER BELL
  - SMOKER DETECTOR WITH SOUNDER BELL AND EXPIRY DATE
  - HEAT DETECTOR
  - HEAT DETECTOR WITH SOUNDER BELL
  - HEAT DETECTOR WITH SOUNDER BELL AND EXPIRY DATE
  - FIRE ALARM SOUNDER (P) WITH EXPIRY DATE
  - SMOKER WITH SOUNDER BELL
  - MUSIC DETECTOR
  - MUSIC DETECTOR WITH SOUNDER BELL
  - MUSIC DETECTOR WITH SOUNDER BELL AND EXPIRY DATE
  - COVERED CORNER MONITOR AND NIGHT VISION
  - AUDIO SOUNDER WITH SOUNDER BELL
  - MANUAL BELL CALL POINT
  - DETECTOR RESET INDICATOR
  - FIRE ALARM INTERFAC
  - FIRE ALARM PANEL
  - FIRE ALARM REFRESH PANEL
  - WORKING DOOR DETECTOR
  - COMBIBED RELEASE PANEL
  - EXTERNAL SPEAKER (P) WITH EXPIRY DATE
  - INTERNAL INTERCOM CONTROL
  - INTERNAL INTERCOM CONTROL UNIT
  - REQUEST TO EXIT PUSH BUTTON
  - EMERGENCY DOOR RELEASE GREEN WITH RED BELL
  - DOOR CONTACT
  - ACTIVS CONTROL FOR BECKER
  - CCTV NETWORK VIDEO RECORDER
  - CCTV CAMERA
  - CCTV CAMERA - INTERNAL
  - CCTV MONITOR

| Rev | Date | Description                         |
|-----|------|-------------------------------------|
| 10  |      | REVISION TABLE - REVISE PANEL ADDED |
| 11  |      | 2024/01 TRIGGER ISSUE               |
| 12  |      | 2024/02 PRELIMINARY ISSUE           |

**watt**  
Energy & Consulting Engineers

45 WINSOR STREET, MANCHESTER, M20 8BA  
T: 0161 438 3103 E: info@wattenergy.co.uk

Client: WESTSHIELD  
Project: HALE BOWLING GREEN SITE  
ASPLEY ROAD  
HALE

Drawing Title: ELECTRICAL SERVICES  
FIRE ALARM & SECURITY LAYOUT  
GROUND FLOOR

Checked By: KH  
Checked By: DW  
Paper Size: A1  
Scale: 1:50

Category: IRIH  
Drawing Reference: WISE/23/E/105  
Drawing Date: 20/1/2024  
Drawing By: YJE

WE RECD DRAWINGS ARE FOR DESIGN INTENT ONLY.  
THE MEP CONTRACTOR IS RESPONSIBLE FOR THE FINAL INSTALLATION DRAWINGS INCLUDING ALL SETTING OUT, DIMENSIONS, ALIGNMENT AND COORDINATION WITH THE ARCHITECT'S REQUIREMENTS